


**REFLECTED CEILING LEGEND**

- RECESSED POTLIGHT LIGHTDOLIER 102/11058X SPECULAR BLACK ALZAK DIFFUSE, DOWN PAR 35 HALOGEN FLOOD PILLIPS LAMP.
- RECESSED POTLIGHT ADJUSTABLE PINHOLE APERTURE, LIGHTDOLIER 102.N/1058X 74.2V
- AS ABOVE EXCEPT USE 55W PAR35HSP
- TRACK LIGHT, LIGHTDOLIER, BEZEL/LOW PROFILE 8201AK/8237OK, T5V PAR 30 HFL, 11YTESPAN TRACK 550126K, 6'-0", 8'-0", 12'-0" LONG, USE VARIABLE ANGLE CONNECTORS FOR 6'-0" TRACKS.
- NON-NEON CLEAR ROPE LIGHT
- RETROFIT EXISTING FLUORESCENT 2'x4' FIXTURE. 'E' DENOTES FIXTURE TO BE IN PLACE.
- EXISTING SURFACE MOUNTED FLUORESCENT FIXTURE.
- EXISTING UNDER CABINET FLUORESCENT FIXTURE.

- △ EMERGENCY LIGHTS MOUNTED 90" A.F.F.
- ⊖ AS LIGHT SWITCH TO CONTROL ALL FIXTURES NOT INDIVIDUALLY SWITCHED, 3-WAY, BK PLATE
- ⊖ LIGHT SWITCH, BLACK PLATE, '3' DENOTES 3-WAY
- ⊖ EXISTING FIRE ALARM & PULL
- ⊖ EXISTING WALL EXIT LIGHT, 'N' DENOTES NEW
- ⊖ EXISTING CEILING FAN
- ⊖ SMOKE DETECTOR

NOTE: ALL LIGHT FIXTURES TO BE GELBAC RESTRAINED.  
 READ PLAN IN CONJUNCTION WITH EXISTING HVAC MECHANICAL DRAWING. DIFFUSERS ON FLEXIBLE PIPE TO BE ADJ. WITHIN A 5'-0" SPACE.  
 PAINT OUT ALL DIFFUSERS & GRILLS CEILING COLOR B.A.#HC1ST DK NAVY BLUE

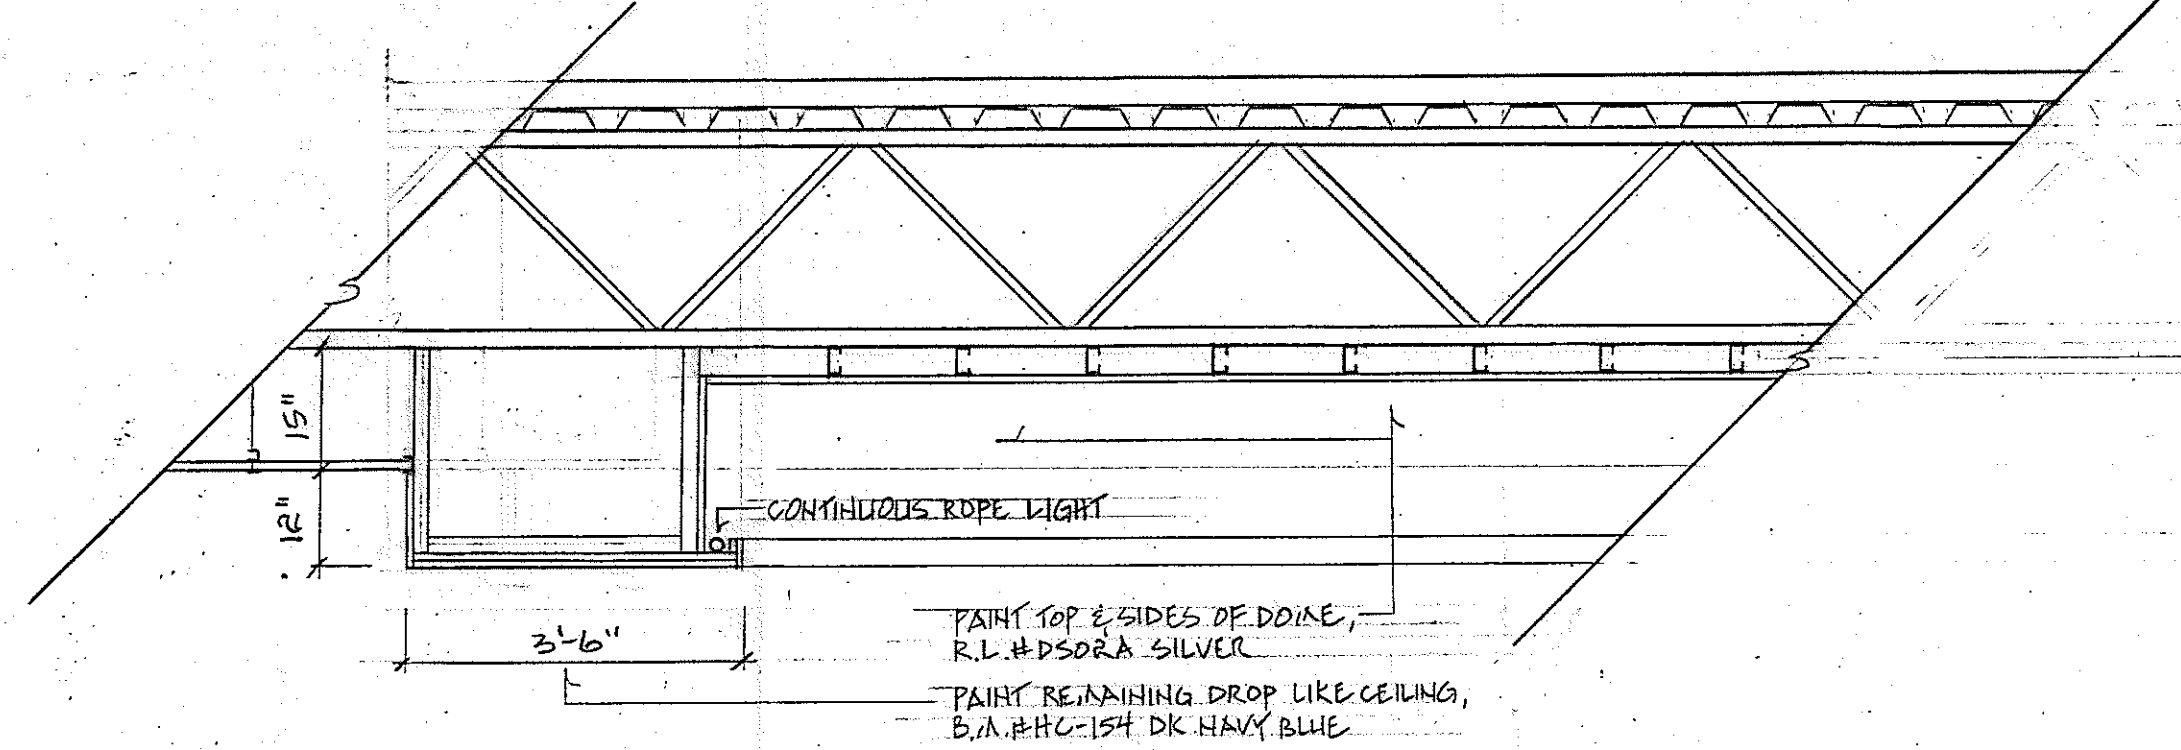

**DOME SECTION ELEVATION**  
 SCALE: 1/2" = 1'-0"

- BUILD PERIMETER DOME WITH 7/8" A.W.B. & 3/8" x 1/2" STEEL STUD, FASTEN TO TRUSS.
- BUILD PERIMETER DROP WITH 7/8" A.W.B. STEEL STUD & 7/8" A.W.F., FASTEN TO TRUSS.
- PAINT TOP & SIDES OF DOME, K.L.#D508A SILVER
- PAINT REMAINING DROP LIKE CEILING, B.A.#HC1ST DK NAVY BLUE

**REFLECTED CEILING PLAN**  
 SCALE: 1/4" = 1'-0"

**C.B.W. CONSTRUCTION LTD.**

THE CRYSTAL SALES OFFICE  
 STATION SQUARE, UNIT 32, BUILDING 'D'  
 METROTOWN, BURNABY, B.C.

REVISION DATE: 4 JUNE, 1997  
 REVISION DATE: 9 JUNE, 1997

DESIGNER: C.M. ROOT  
 DATE: 21 MAY, 1997  
 SCALE: AS SHOWN  
 PAGE: 2 OF 2

REFLECTED CEILING PLAN

CONTRACTORS SHALL VERIFY & BE RESPONSIBLE FOR ALL DIMENSIONS ON THE JOB & THE DESIGNER SHALL BE NOTIFIED OF ANY DISCREPANCIES & VARIATIONS ON DRAWINGS.